


PLAN VIEW

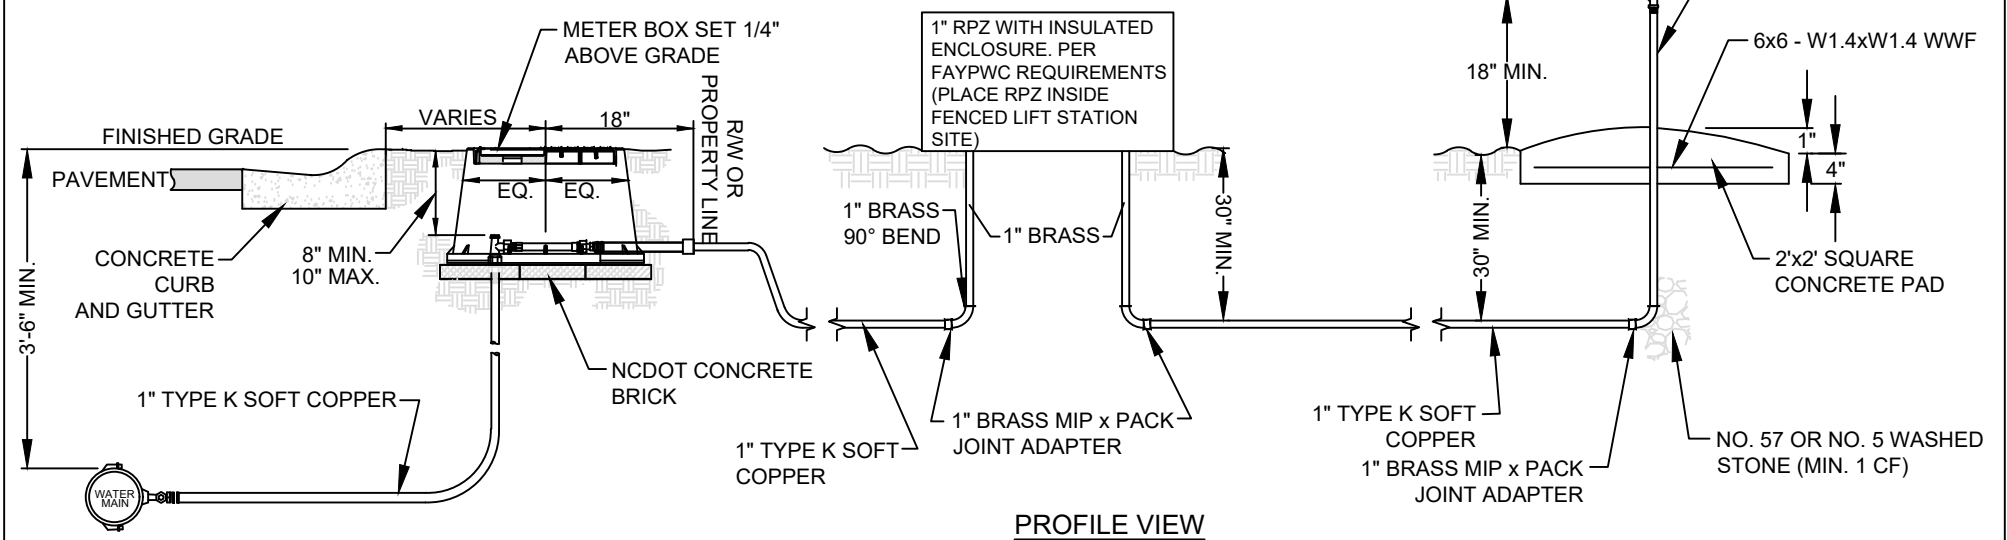

PROFILE VIEW

- NOTES:
1. INSTALLATION SHALL BE IN ACCORDANCE WITH FAYPWC STANDARDS.
 2. LATERAL SHALL BE INSPECTED AND APPROVED BY FAYPWC PROJECT COORDINATOR PRIOR TO BACKFILL.
 3. REFER TO APPROVED LIFT STATION SITE PLAN FOR EXACT LOCATIONS.

<p>YARD HYDRANT INSTALLATION N.T.S.</p>		<p>FAYETTEVILLE PUBLIC WORKS COMMISSION FAYETTEVILLE, N.C.</p>			NO.	DATE	REVISION
					1	07/17	REVISED NOTES
<p>SHEET NO. 1 OF 1</p>	DWG. NO.	W.27	DWG. BY:	FAYPWC	<p>WATER RESOURCES ENGINEERING DEPARTMENT</p>		
	DATE:	JAN. 01, 2025	APPROVED BY:	K.A.H.			